



SJ LIGHTING, INC.
 LIGHTING CONSULTATION • LIGHTING DESIGN • PRODUCTION DESIGN
 SYSTEMS INTEGRATION • PROGRAMMING • SALES • RENTALS

SJ Lighting, Inc.
 Agoura Hills, CA
 818-874-9779 ph
 818-495-0816 fax
 info@sjlighting.net
 www.sjlighting.net

THE ORIGINAL ASSOCIATES
 PARTNERSHIP IS COPROTECTED MATERIAL
 AND REMAINS THE PROPERTY OF THE
 DESIGNER.

THIS DOCUMENT IS FOR ONE TIME USE ONLY
 AT THE SPECIFICATION AND IS NOT
 TO BE REPRODUCED, COPIED, PRINTED OR
 TRANSMITTED IN ANY FORM OR BY ANY
 MEANS, WITHOUT THE WRITTEN
 PERMISSION OF THE DESIGNER.

DESIGNER IS NOT A STRUCTURAL
 ENGINEER AND THESE DIMENSIONS AND
 ARE NOT INTENDED AS ENGINEERING
 RESPONSIBILITY IS RESERVED AND THE
 STRUCTURAL INTEGRITY OF ANY
 EQUIPMENT PROVIDED BY ANYONE.



- General Notes:**
- All 10-ft truss lengths have 1 x LED PAR truss warmer / per truss
 - All atmospheric effects placement to be finalized onsite by designer
 - All truss lengths are 20.5" @ 10'-0", 8'-0", or 5'-0" unless otherwise indicated
 - Substitutions will be verified by designer

Rev #	Revision	Date	Drawn
001	Prelim Drawings	12.01.14	ASA
002	DJ Booth/New Truss	01.13.15	MTR
003	DJ Facade/LIS Truss	02.09.15	MTR
005	Value Engineering	02.17.15	MTR
007	Overhead Video/Lights	03.11.15	MTR
###	Revision Issue	###.###.##	---
###	Revision Issue	###.###.##	---
###	Revision Issue	###.###.##	---
###	Revision Issue	###.###.##	---

Ultra Worldwide

UMF Miami

Mar. 27-29, 2015

Miami, FL

301 Bascayne Blvd.
 Miami, FL 33132

Midpark

Project ID:
 UMF2015.MIDPARK.007a

Issue Date:
 03.11.15


Drawn By: SJL
 ASA

Scale: See Drawing

Front Elevation

DD

02

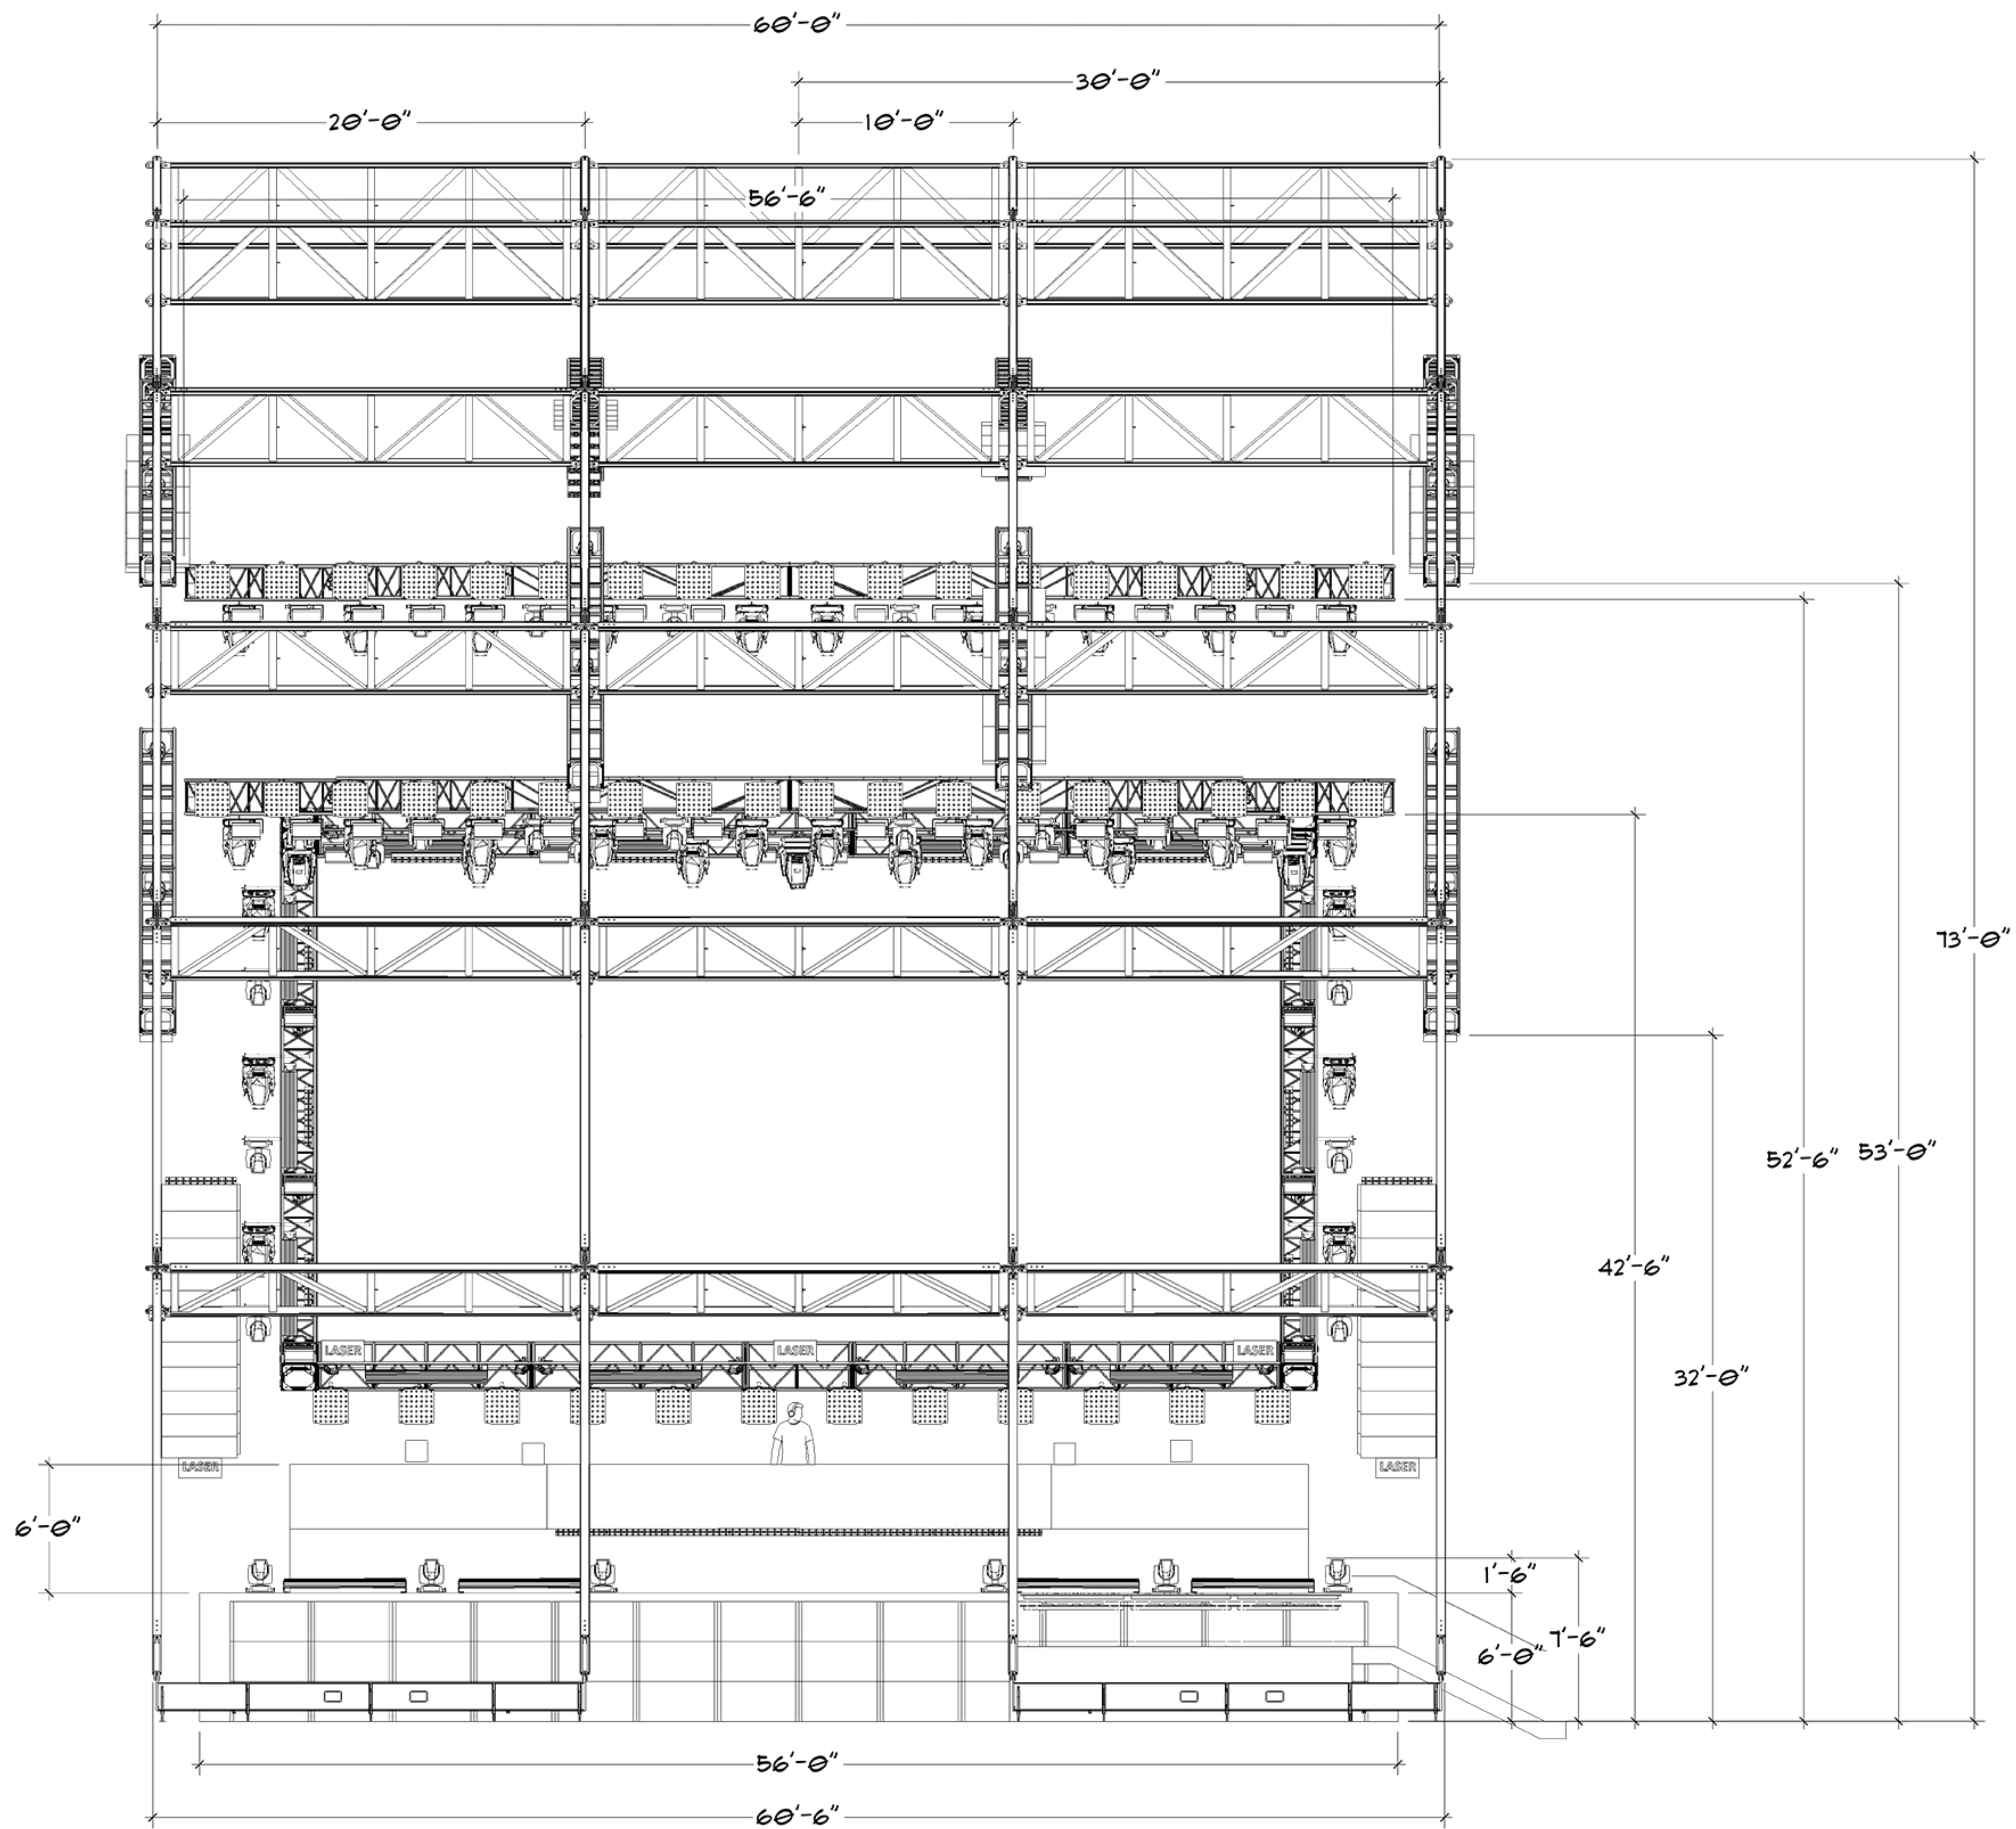

Full - Front Elevation
 Scale: To Fit

DD02
 01

Key to Symbols

Mac Viper Spot Qty: 030	Mac 2k Wash Qty: 003	Sharp Qty: 032	Atomic 3000 Strobe Qty: 044	CO2 Jet Qty: 004	LED PAR Qty: 052	KR-10 Qty: 020	Colorforce 72 Qty: 018	Nexus Panel 7x7 Qty: 048	Nexus Panel 4x4 Qty: 042	500mm Video Tile Qty: TBD	Custom DJ Booth (edge lit on surface) Qty: 001	10' @ 20.5" Truss Qty: 038	5' @ 20.5" Truss Qty: 002	20.5" Corner Block Qty: 004	40' OD 90° @ 20.5" Truss Qty: 002	3' Pipe Qty: 071